



工程设计资质证书编号
建筑甲级:A113007169
园林甲级:A113007169
规划乙级:城规142010
市政乙级:A213007166
人防乙级:A213007166

中盛弘宇建设科技有限公司
Zhongsheng Hongyu Construction Technology Co., Ltd.

备注 NOTE
*本图经施工图审查机构及消防审批部门审查合格方可用于施工。
版权归属中盛弘宇建设科技有限公司所有，未经许可，不得擅
自使用、更改和复制等其它用途。
This drawing can only be used for construction after being
examined to be qualified and approved by Drawing Appraisal
Unit & Fire Control Committee. The copyright belongs to the
engineering design technology co., LTD. Without
written permission, it's prohibited to use, change or copy
the drawing for other purposes.

合作设计单位 CO-OPERATED WITH

说明 EXPLAIN

审定 APPROVED BY	支永涛	支永涛
审核 VERIFIED BY	李亮	
项目负责人 PROJECT CHIEF	宋志荣	宋志荣
专业负责人 PROFESSION CHIEF	支永涛	支永涛
校对 CHECKED BY	周兴	周兴
设计 DESIGNED BY	周浪	周浪

建设单位 CONSTRUCTION
重庆华牧现代农业有限公司







 


工程名称 PROJECT
华牧现代农业生态循环智能化蛋鸡项目配电工程

项目名称 SUB PROJECT

图纸名称 DRAWING TITLE
1600kVA箱变10kV出线柜二次接线图(真空断路器)

阶段 PHASE	施工图	专业 SPECIALTY	电气
比例 SCALE		图号 DRAWING NO.	
日期 DATE	2023.04	版本号 VERSION NUMBER	A

签字齐全 盖章有效

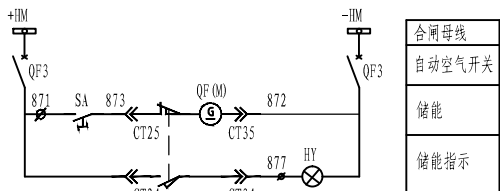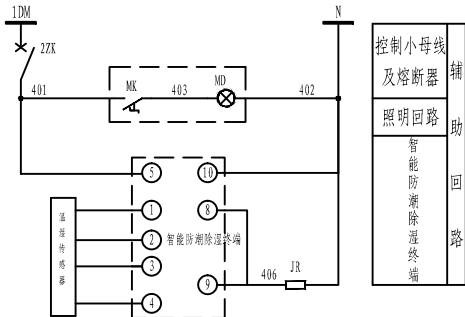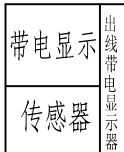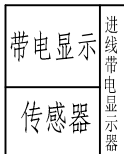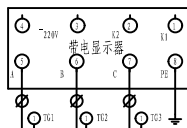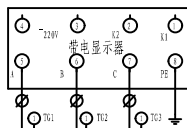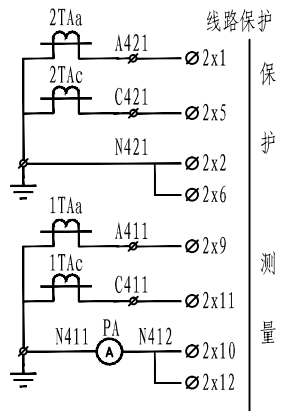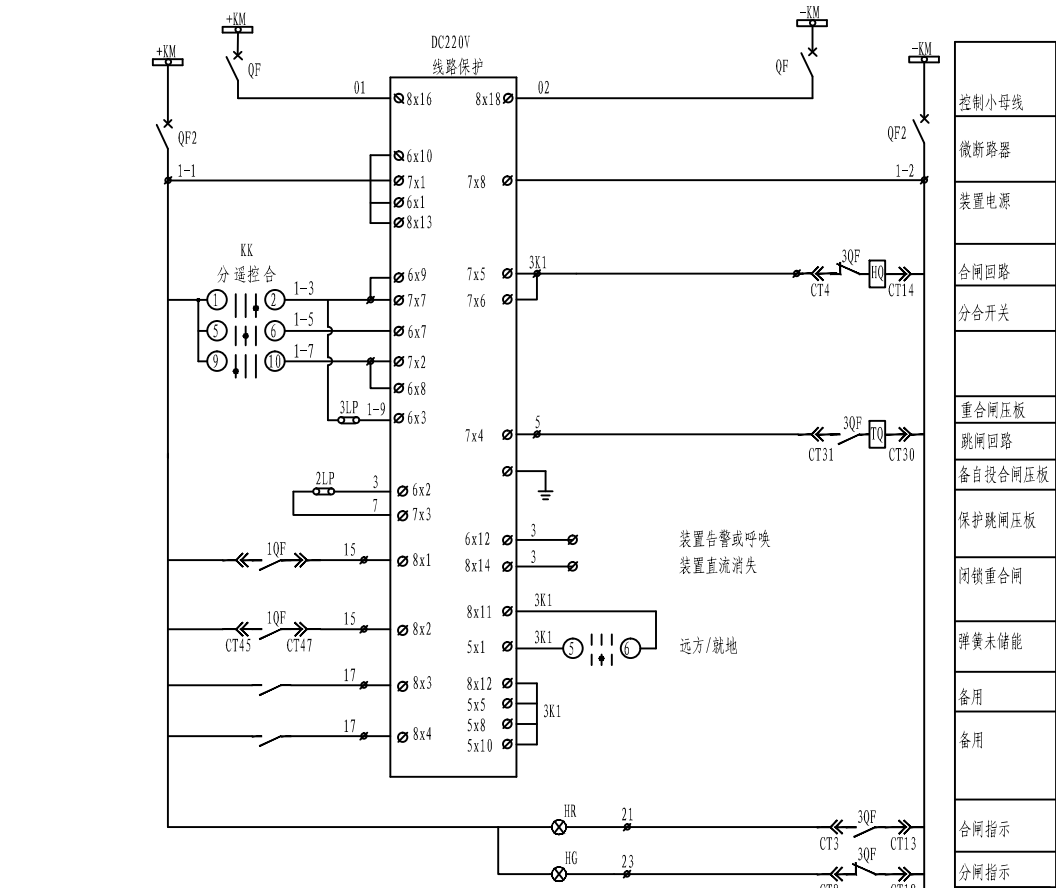

1YMn 1YMc 1YMb 1YMa

